

All Cats Health Clinic
Dr. Jennifer Palmer
4420 Fieldcrest Court
Cumming, GA 30040

Drawn By: CDO
Checked By: PUH


Release/Revision Schedule
02.26.09 FLOORPLAN NO. 1

HDA Job Number: 0810

This drawing is an instrument of service & shall remain the property of the Architect. Do not reproduce, publish or use in any way without the consent of the Architect.

not released for construction

P-1

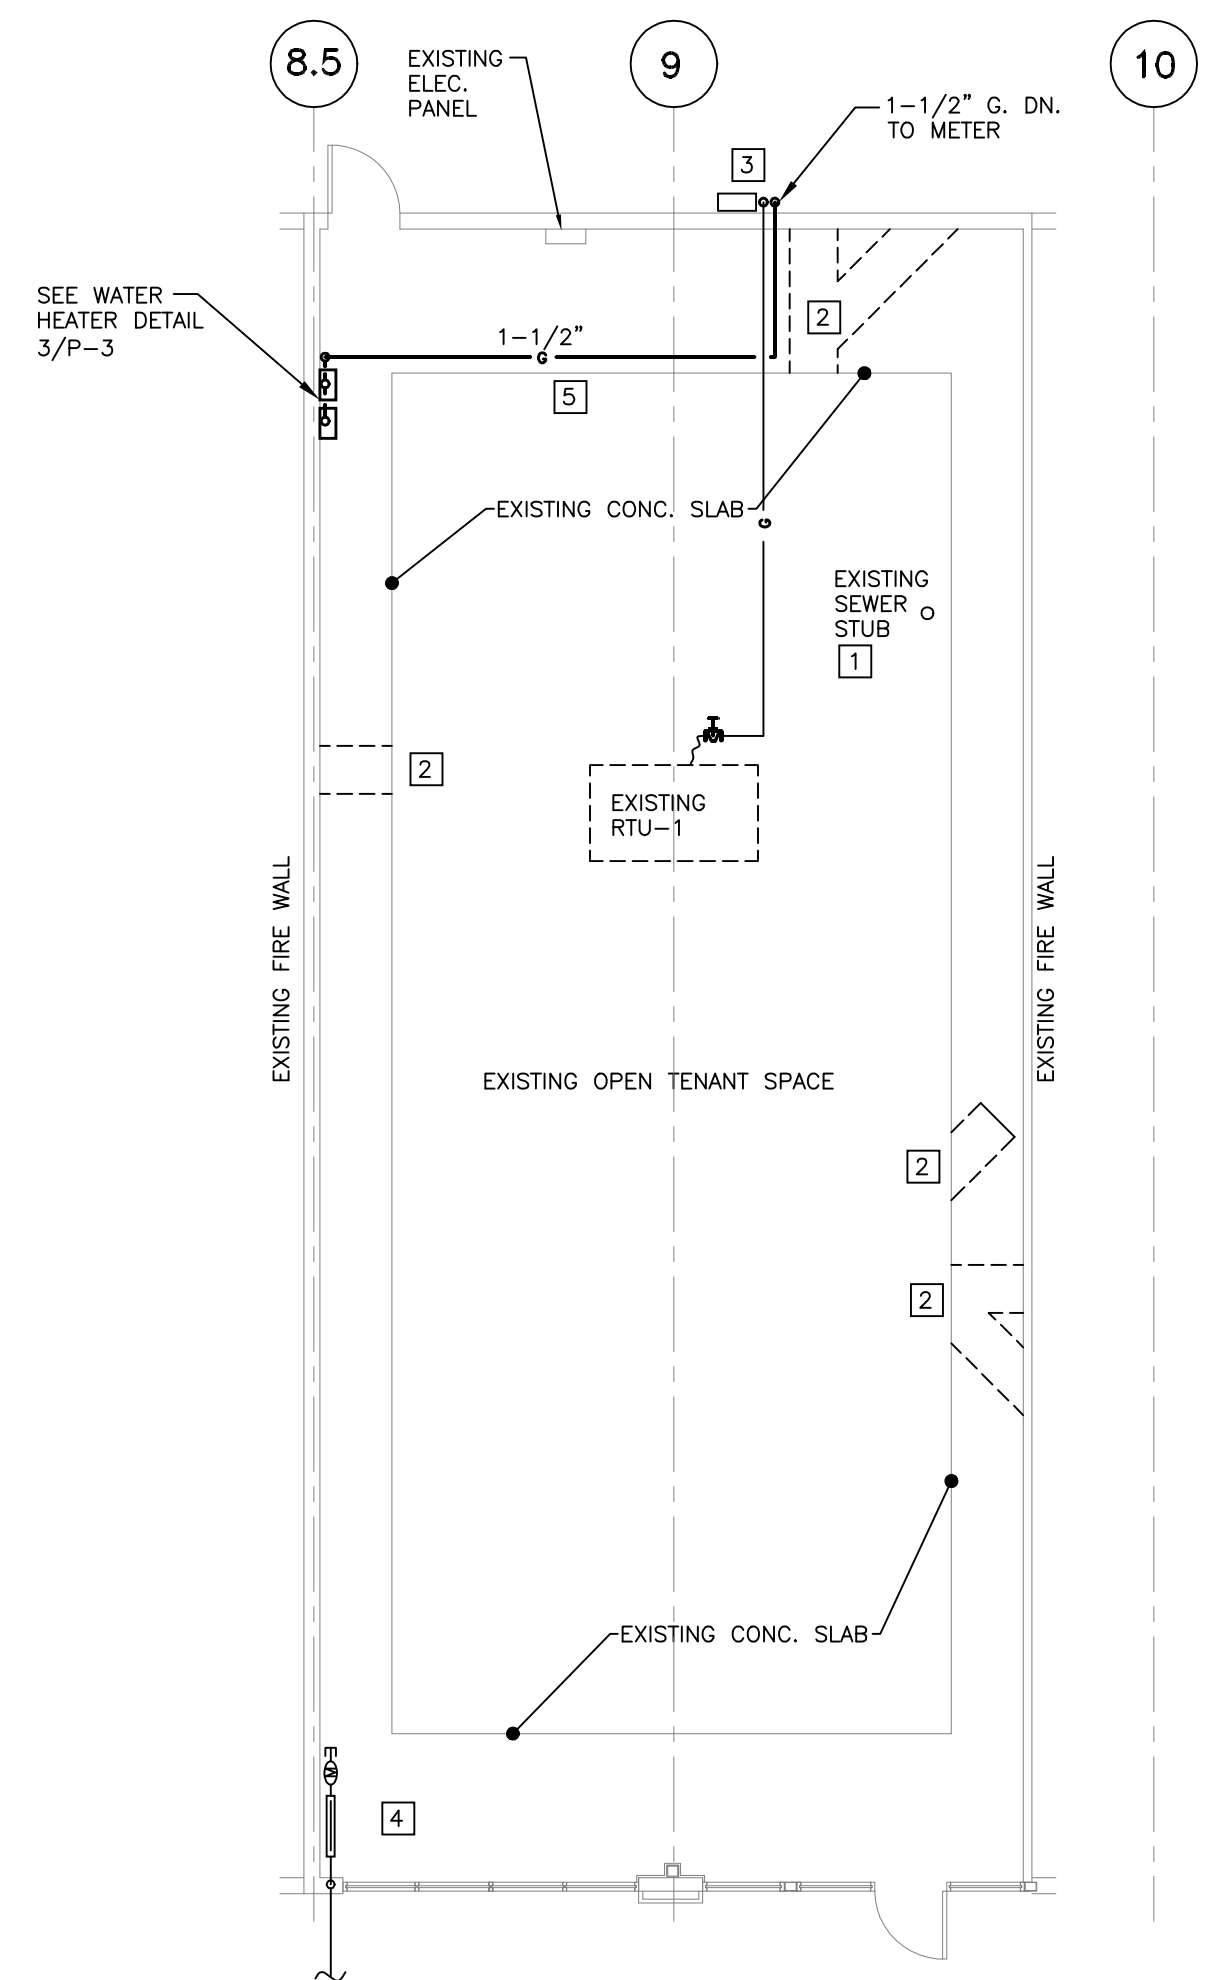


1 EXISTING FLOOR PLAN - PLUMBING
1/8" = 1'-0" NEW GAS PIPING SHOWN HERE ALSO

3 KEYED NOTES - DEMOLITION

- 1 FIELD VERIFY EXISTING TENANT SEWER STUBOUT AND SIZE. SHOWN AS A 4" SANITARY.
- 2 CUT & PATCH EXISTING CONC. SLAB. SAW CUT 2' WIDE FOR DRAIN PIPE TRENCH.
- 3 FIELD VERIFY LOCATION OF EXISTING GAS METER & SERVICE
- 4 FIELD VERIFY LOCATION OF EXISTING 3/4" WATER SERVICE LINE WITH PRESSURE REDUCING STATION, SUB-METER & CUTOFF VALVE TO BE REPLACED WITH & 1-1/4" SERVICE LINE.
- 5 1-1/2" G. GAS LINE TO WATER HEATERSABV. CLG. FROM GAS METER. SEE SHT. P-3 FOR ELECTRIC WATER HEATER ALTERNATE.

4 EQUIPMENT SCHEDULE

NO.	ROOM	DESCRIPTION	PROVIDED BY	INSTALLED BY
115	02	GL	OWNER	OWNER
102		STAINLESS STEEL TOP	OWNER	CONTRACTOR
103		STAINLESS STEEL TOP	OWNER	CONTRACTOR
104		NOT USED	OWNER	CONTRACTOR
104		STORAGE	OWNER	CONTRACTOR
105		DENTAL UNIT	OWNER	CONTRACTOR
107		ANESTHESIA MACHINE	OWNER	OWNER
107		CAGES	OWNER	CONTRACTOR
107		A-RAY TABLE	OWNER	CONTRACTOR
108		UNDERCABINET REFRIGERATOR	OWNER	CONTRACTOR
108		UNDERCABINET REFRIGERATOR	OWNER	CONTRACTOR
108		WET TABLE	OWNER	CONTRACTOR
109		SURGERY TABLE	OWNER	CONTRACTOR
108		CAGES	OWNER	CONTRACTOR
111		CAGES	OWNER	CONTRACTOR
112		WASHER	OWNER	CONTRACTOR
112		OWNER	OWNER	OWNER
115		FREEZER	OWNER	CONTRACTOR
114		STORAGE	OWNER	OWNER
115		TANKLESS WATER HEATER	OWNER	CONTRACTOR
115		CENTRAL VACUUM	OWNER	CONTRACTOR
115		GROOMING TABLE	OWNER	CONTRACTOR
114		REFRIGERATOR	OWNER	CONTRACTOR

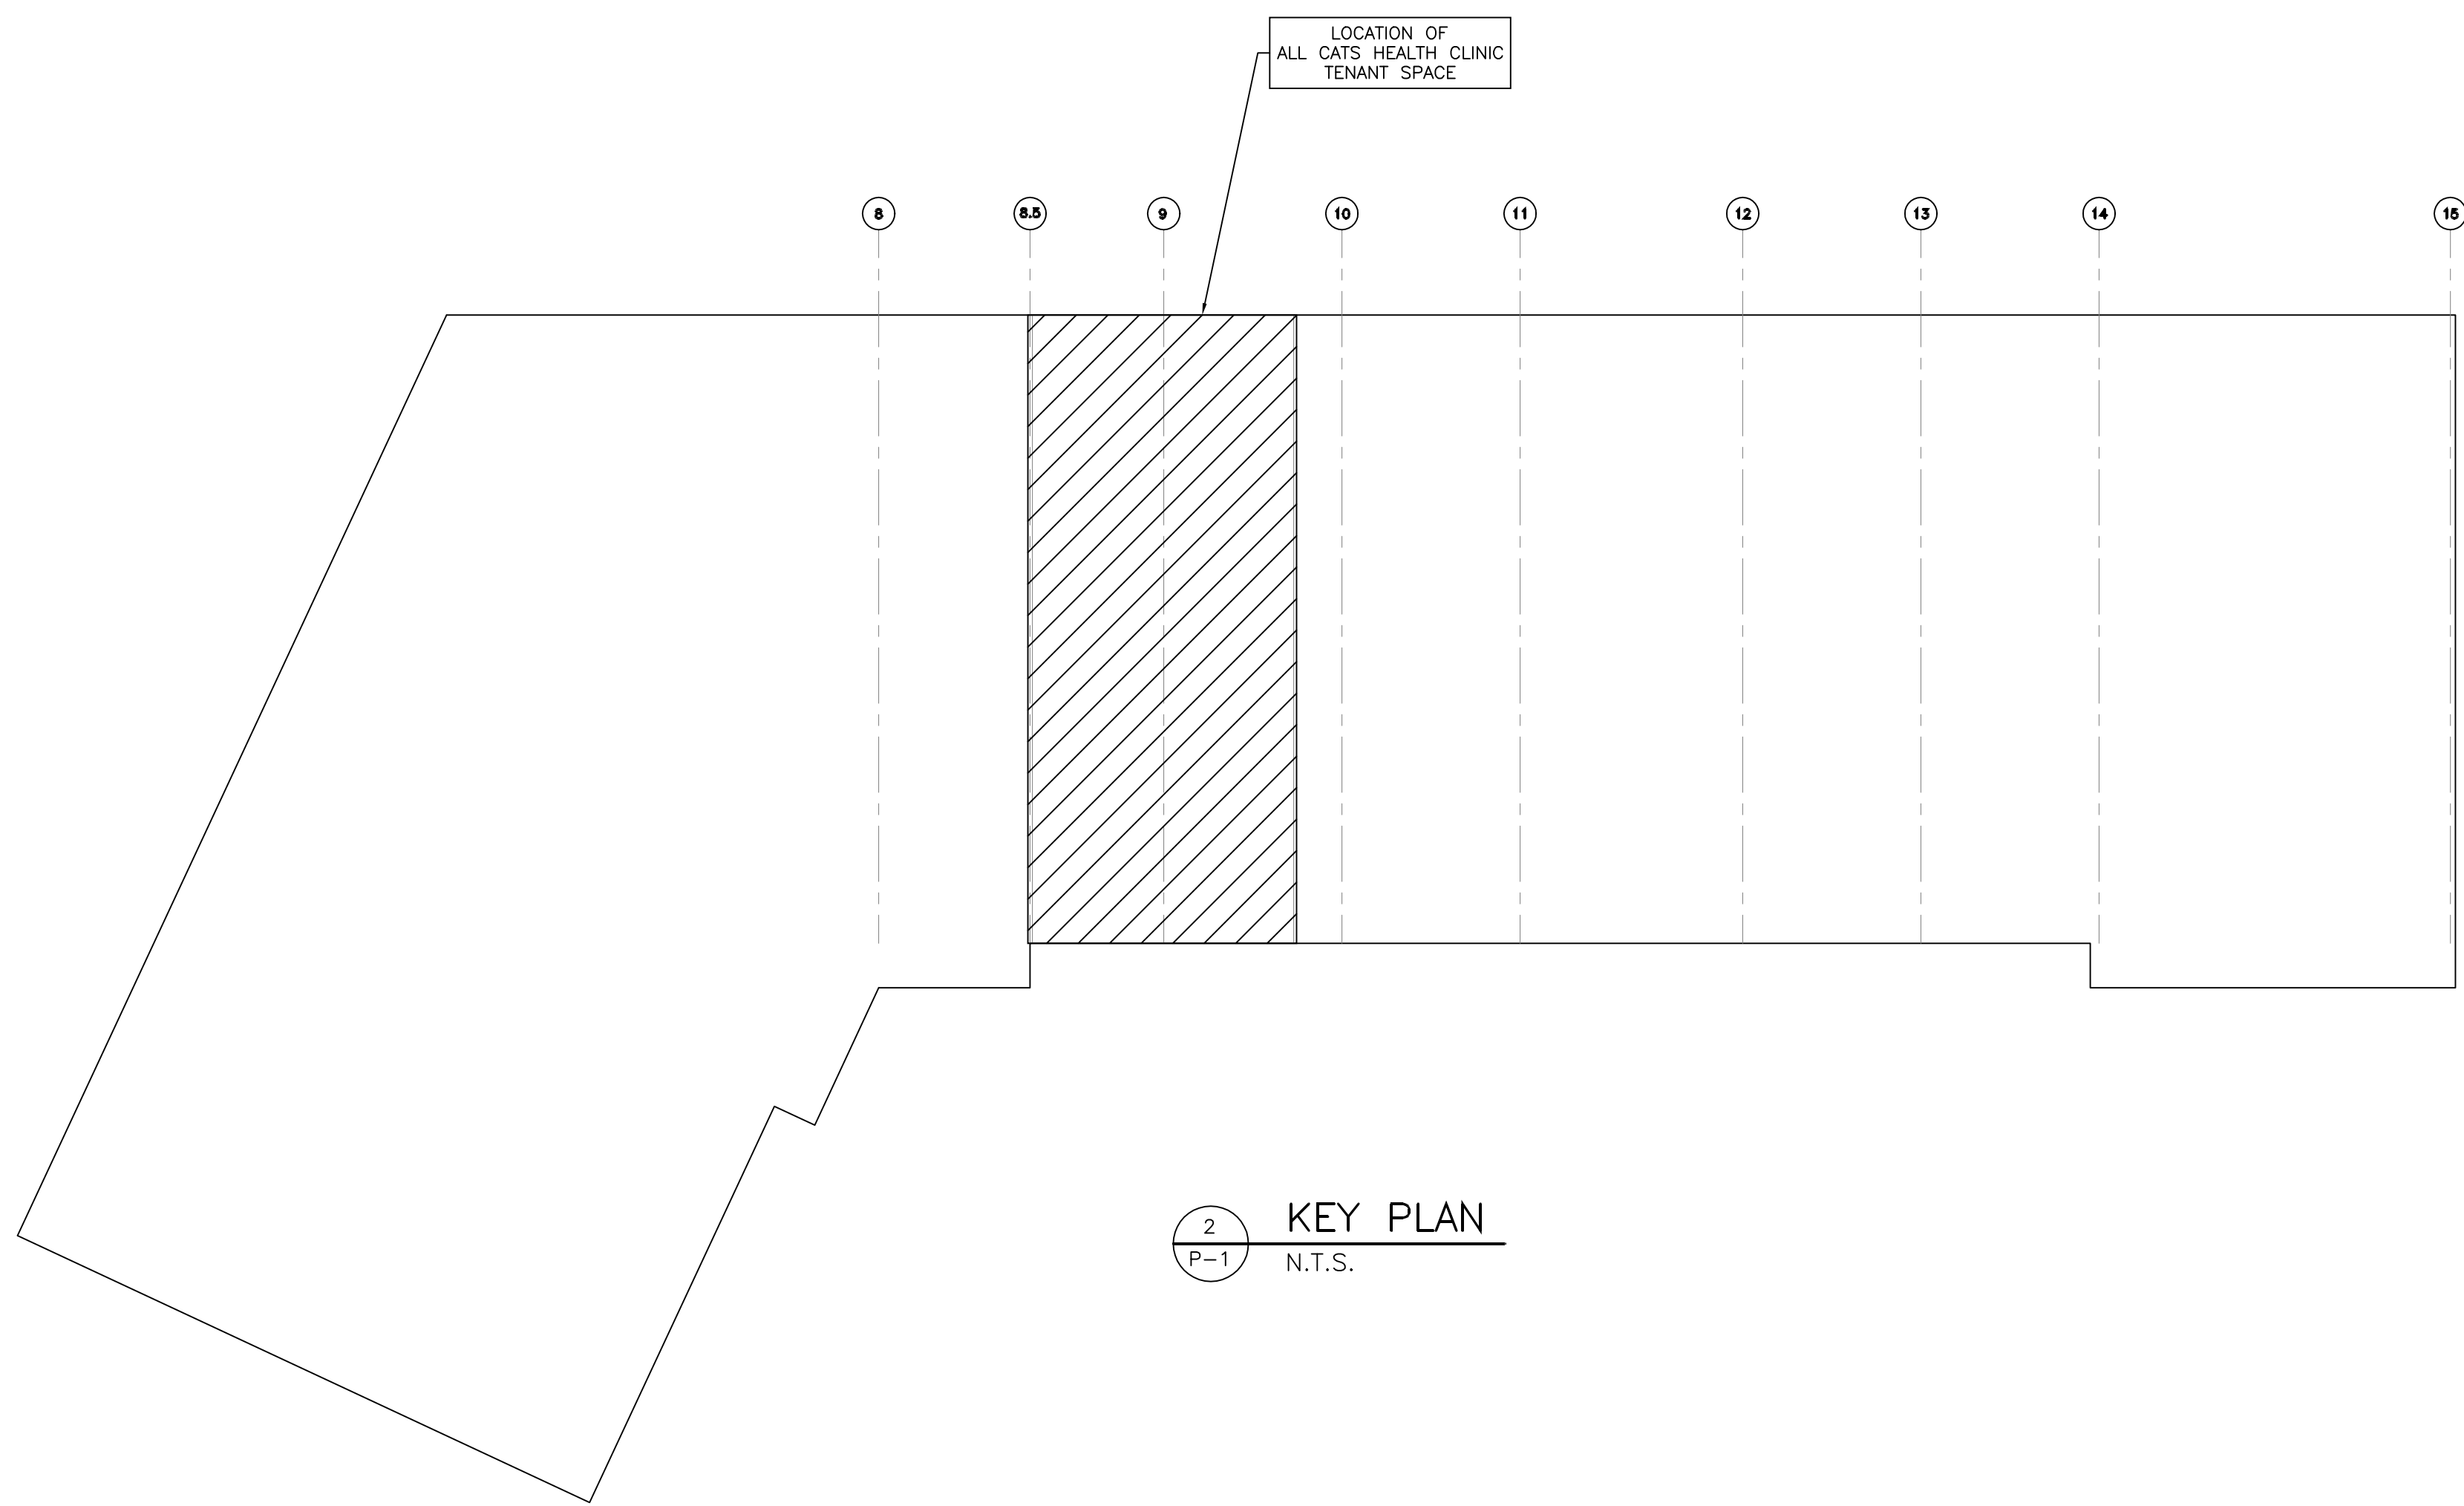

2 KEY PLAN
N.T.S.